

**Lighting Key**

- House Lights
- Fluorescent lights
- Stage Blue Lights
- HVAC ceiling grille
- Prolights CT+ (25-50deg)
- ShowPro LED Fresnel RGBAL
- Prolights Eclipse Cyc100

Note: Fitting Numbers references fittings from a control perspective  
Other information like DMX addressing is in the Supplied Table

**Electrical Key**

- Double 10amp Power Outlet
- Single 10amp Power Outlet
- Camera
- ELC 3 Channel DMX Node
- DMX Comms Panel

Extent of Mezzanine floor shown dashed over ramp Smother and cyc  
ramp up  
2 x Looms, each 1-4  
Loom A 1-12  
Loom D 1-12  
Rack:  
2x 12 Dim  
2x 12 Way Power  
DMX Patch  
Half Stage Tabs  
Loom B 1-12  
Stage level  
Curtain Leg  
Loom C 1-12  
House Curtain

Scale 1:100 0 3m

Supplied By:  
**LIGHTHAUS**



**TSB SHOWPLACE**

92 Devon St New plymouth  
tsbshowplace@npdc.govt.nz  
PH 06 759 6712

Project Title:  
**TSB Showplace  
Lighting upgrade**

Drawing:  
**Theatre Royal Stage Lighting Plan**


Site Address:  
**TSB Showplace  
92 Devon Street  
New Plymouth**

Status:  
**As Built**

REVISION	ISSUED BY	DESCRIPTION	DATE
A	DM	For Approval	10/1/23
B	DM	For Approval - Following Comments	16/1/23
C	DM	As Built	20/2/23
D	DM	As Built - Added Additional Bars	2/3/23

**Revision Schedule**

Project No.	Date:	
10/1/2023	10/1/2023	
Drawn By:	Scale:	
Dave Morrison	NTS	
Checked By:	Sheet No:	Revision:
Nick Reeves	3 of 3	D

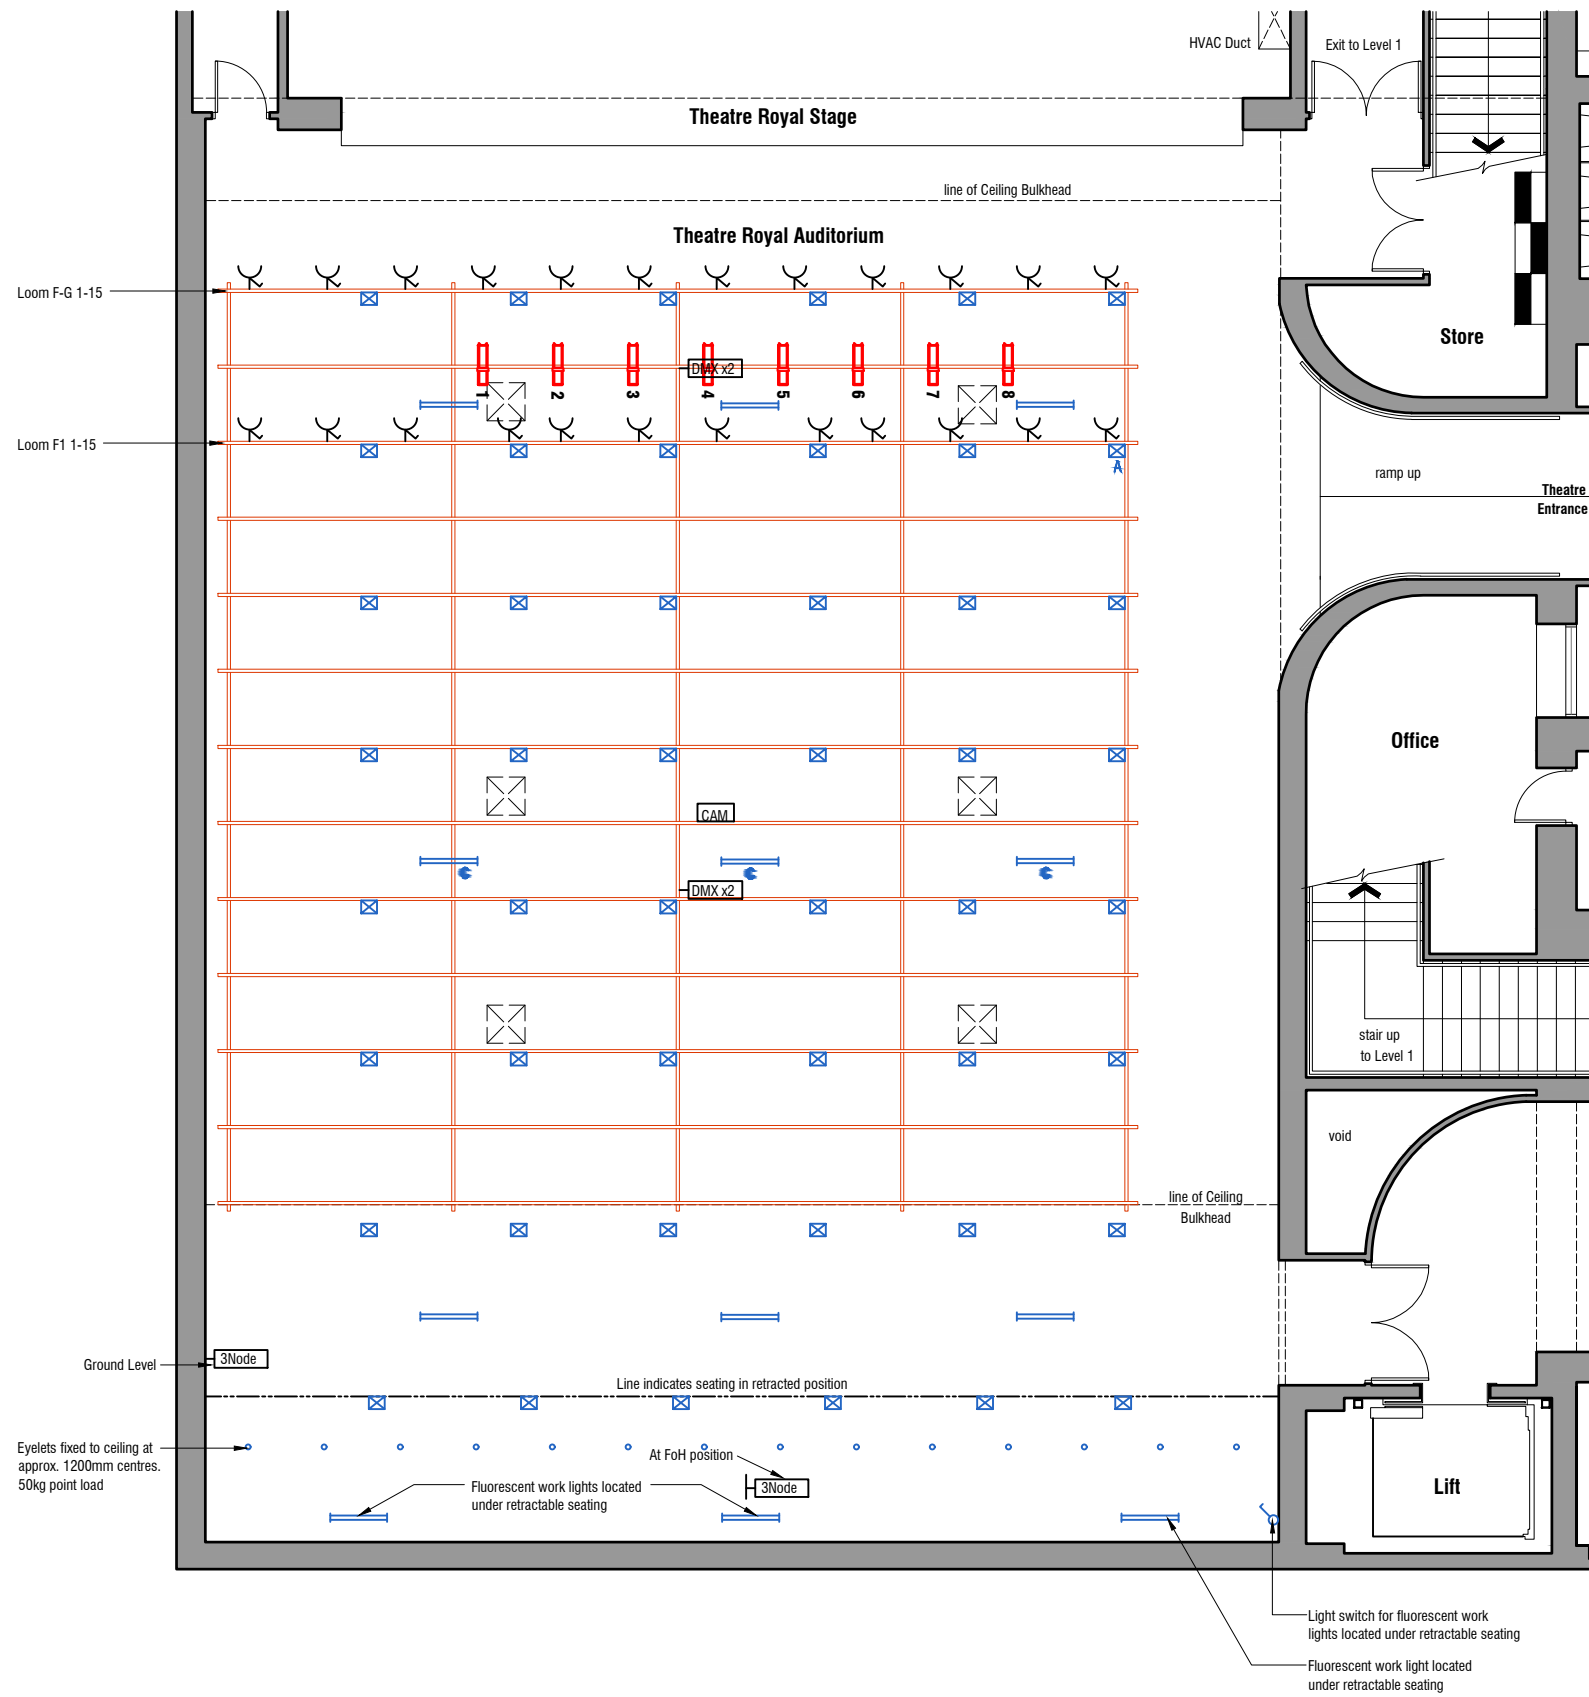

**Lighting Key**

- House Lights
- Fluorescent lights
- Stage Blue Lights
- HVAC ceiling grille
- Prolights CT+ (25-50deg)
- ShowPro LED Fresnel RGBAL
- Prolights Eclipse Cyc100

Note: Fitting Numbers references fittings from a control perspective  
Other information like DMX addressing is in the Supplied Table

**Electrical Key**

- Single 10amp Power Outlet
- Camera
- ELC 3 Channel DMX Node
- DMX Comms Panel

Supplied By:  
**LIGHTHAUS**



**TSB SHOWPLACE**

92 Devon St New plymouth  
tsbshowplace@npdc.govt.nz  
PH 06 759 6712

Project Title:  
**TSB Showplace  
Lighting upgrade**

Drawing:  
**Theatre Royal Auditorium Lighting Plan**

Site Address:  
**TSB Showplace  
92 Devon Street  
New Plymouth**

Status:  
**As Built**

REVISION	ISSUED BY	DESCRIPTION	DATE
A	DM	For Approval	10/1/23
B	DM	For Approval - Following Comments	16/1/23
C	DM	As Built	20/2/23
D	DM	As Built - Following Comments	2/3/23
Revision Schedule			

Project No.	Date:
Drawn By: Dave Morrison	10/1/2023
Checked By: Nick Reeves	Scale: NTS
	Sheet No: 2 of 3
	Revision: D

Theatre Royal House Rig Patch

Lighting Upgrade 2023 - As Built

Universe 1							
Unit Type	Unit #	Universe	Address	Location	Channels	Mode	Lens
Prolights CT+	1	1	1	FOH	12	Extended	25-50 Deg
Prolights CT+	2	1	13	FOH	12	Extended	25-50 Deg
Prolights CT+	3	1	25	FOH	12	Extended	25-50 Deg
Prolights CT+	4	1	37	FOH	12	Extended	25-50 Deg
Prolights CT+	5	1	49	FOH	12	Extended	25-50 Deg
Prolights CT+	6	1	61	FOH	12	Extended	25-50 Deg
Prolights CT+	7	1	73	FOH	12	Extended	25-50 Deg
Prolights CT+	8	1	85	FOH	12	Extended	25-50 Deg
ShowPro LED Fesnel RGBAL	25	1	97	LX1	10	SSP	
ShowPro LED Fesnel RGBAL	26	1	107	LX1	10	SSP	
ShowPro LED Fesnel RGBAL	27	1	117	LX1	10	SSP	
ShowPro LED Fesnel RGBAL	28	1	127	LX1	10	SSP	
ShowPro LED Fesnel RGBAL	29	1	137	LX1	10	SSP	
ShowPro LED Fesnel RGBAL	30	1	147	LX1	10	SSP	
ShowPro LED Fesnel RGBAL	31	1	157	LX2	10	SSP	
ShowPro LED Fesnel RGBAL	32	1	167	LX2	10	SSP	
ShowPro LED Fesnel RGBAL	33	1	177	LX2	10	SSP	
ShowPro LED Fesnel RGBAL	34	1	187	LX2	10	SSP	
ShowPro LED Fesnel RGBAL	35	1	197	LX2	10	SSP	
ShowPro LED Fesnel RGBAL	36	1	207	LX2	10	SSP	
ShowPro LED Fesnel RGBAL	37	1	217	LX3	10	SSP	
ShowPro LED Fesnel RGBAL	38	1	227	LX3	10	SSP	
ShowPro LED Fesnel RGBAL	39	1	237	LX3	10	SSP	
ShowPro LED Fesnel RGBAL	40	1	247	LX3	10	SSP	
ShowPro LED Fesnel RGBAL	41	1	257	LX3	10	SSP	
ShowPro LED Fesnel RGBAL	42	1	267	LX3	10	SSP	
Prolights Eclipse Cyc 100	9	1	277	LX4	10	10 Ch Theatre	
Prolights Eclipse Cyc 100	10	1	287	LX4	10	10 Ch Theatre	
Prolights Eclipse Cyc 100	11	1	297	LX4	10	10 Ch Theatre	
Prolights Eclipse Cyc 100	12	1	307	LX4	10	10 Ch Theatre	
					317		
					316		